


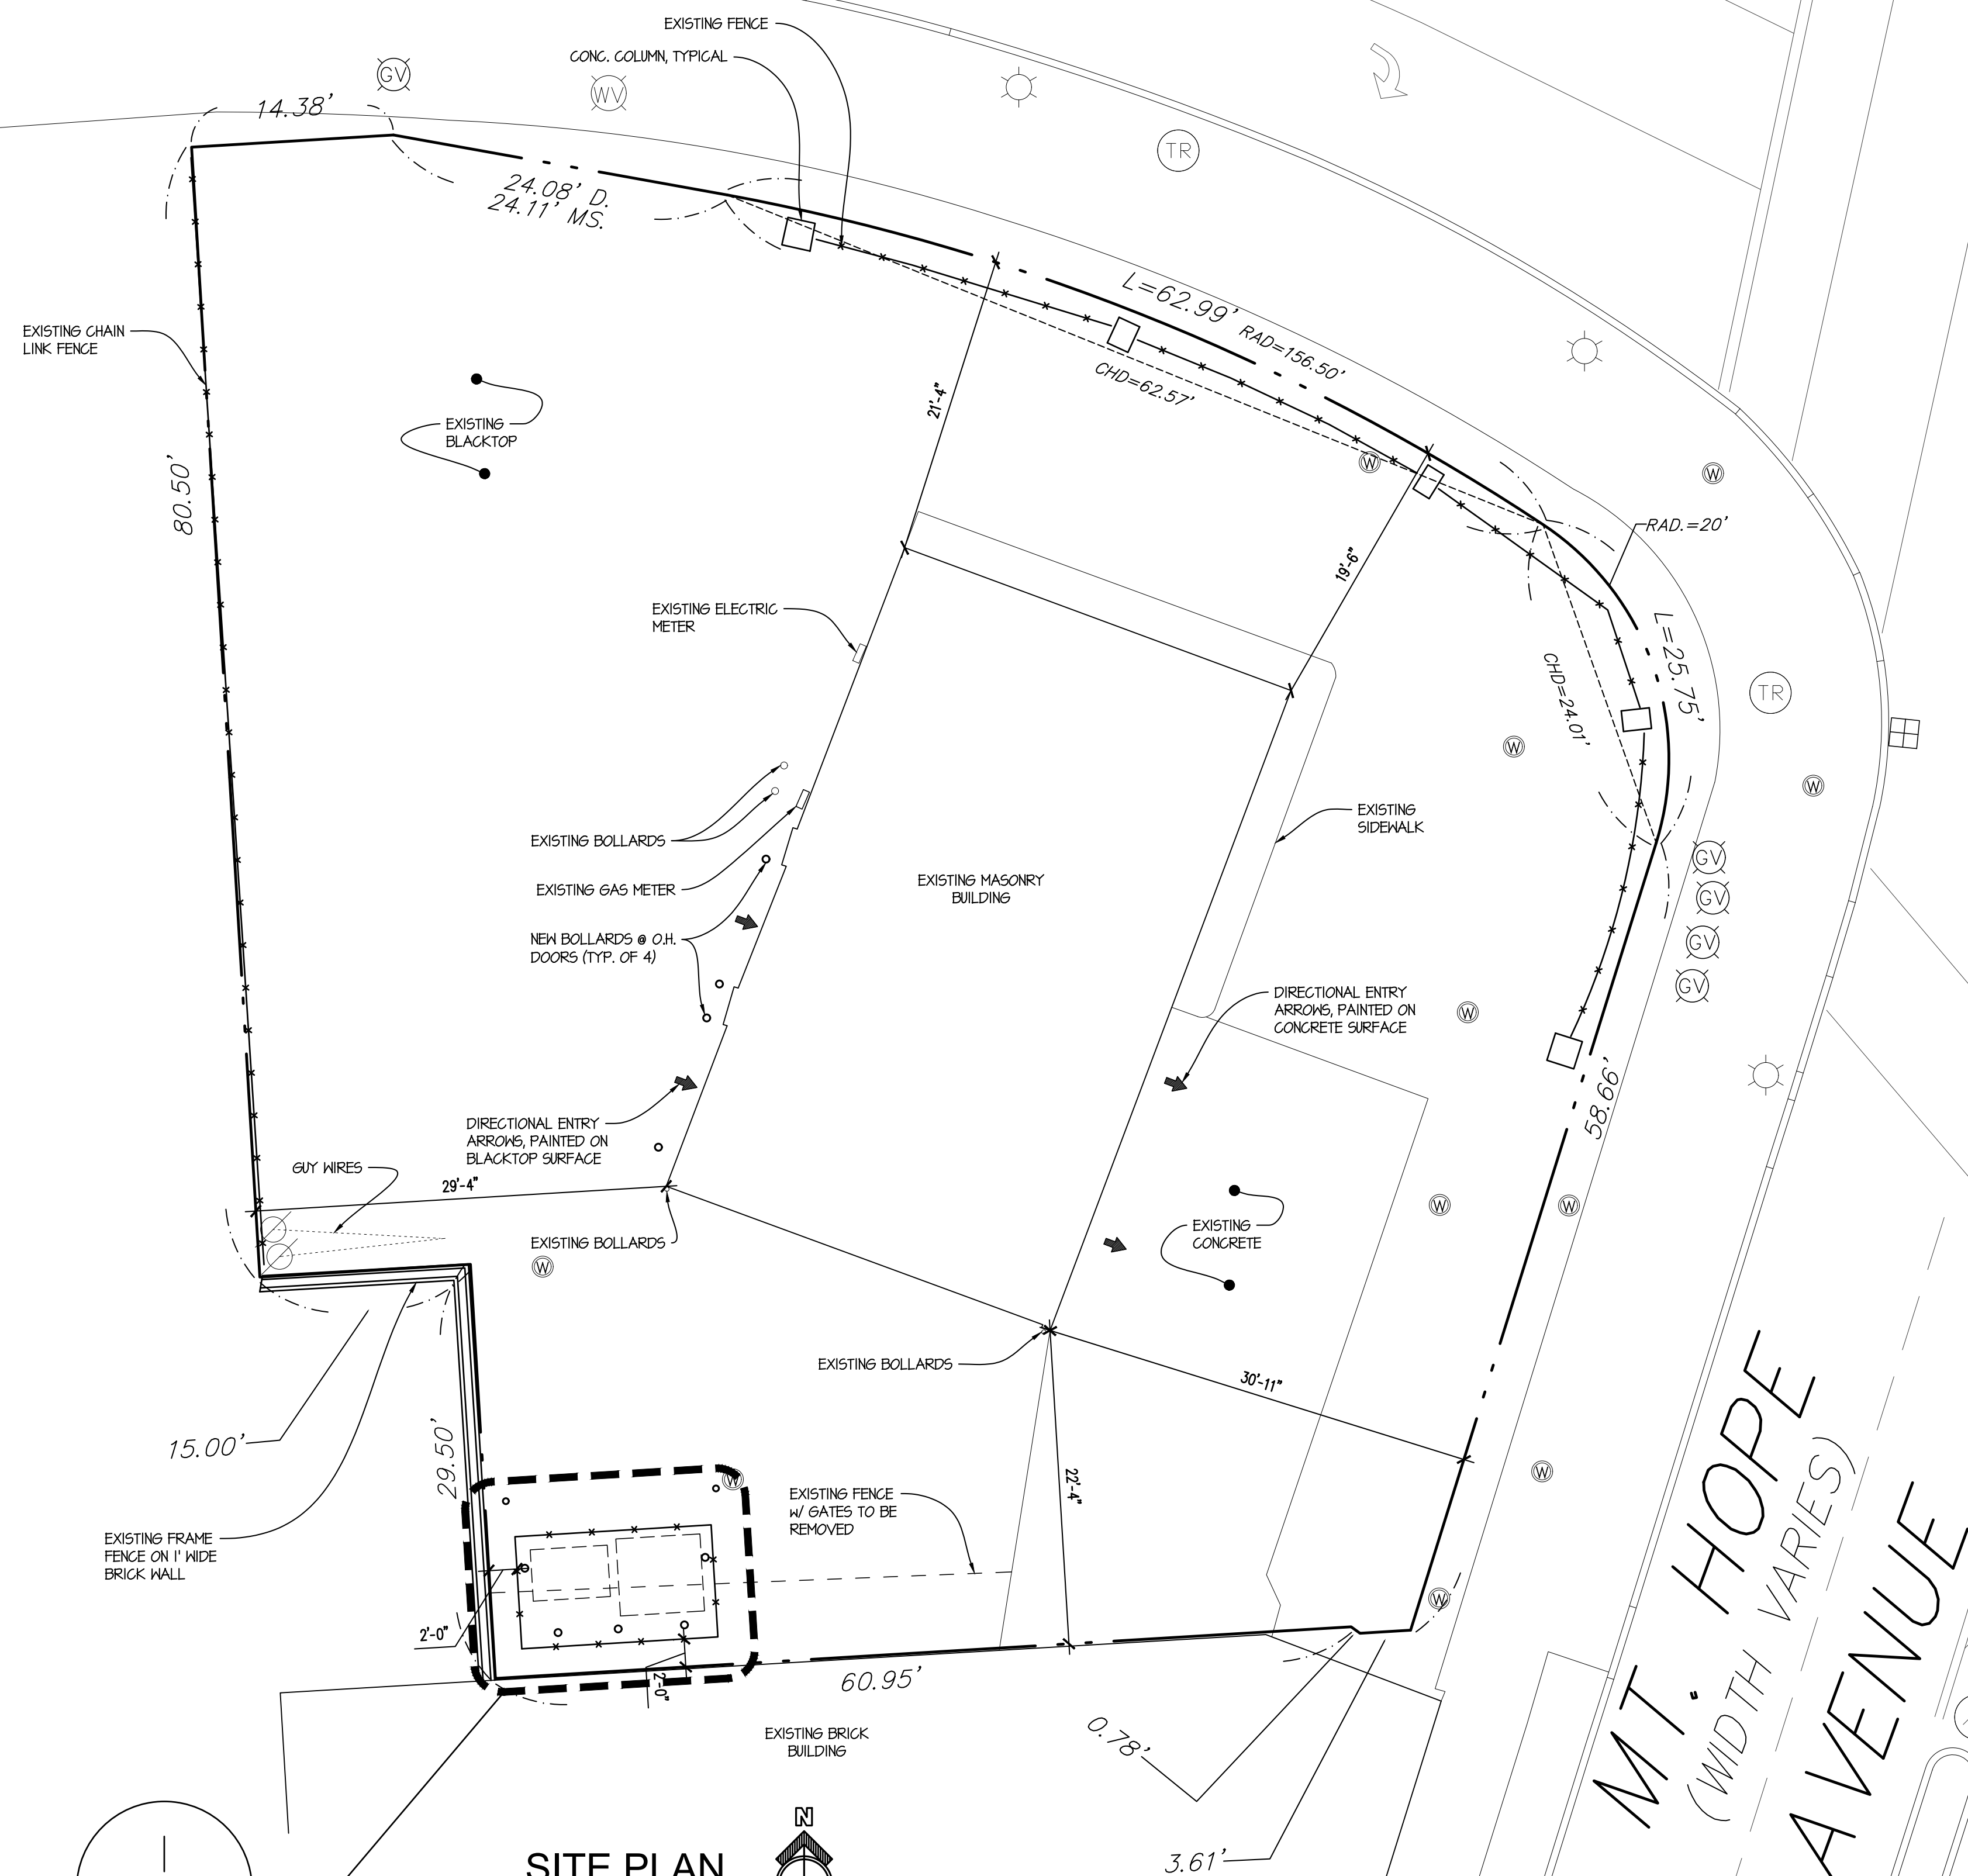












(WIDTH VARIES) ↗ BOULEVARD ↗



LEGEND

-  UTILITY / SERVICE POLE
-  WATER LINE VALVE
-  FIRE HYDRANT
-  D.I. (DROP INLET - STORM)
-  MANHOLE (STORM)
-  MANHOLE (ELECTRIC)
-  MANHOLE (TRAFFIC)
-  MANHOLE (SANITARY)
-  MANHOLE (TELEPHONE)
-  GASLINE MARKER
-  GAS LINE VALVE
-  LIGHT STANDARD
-  SIGN

BIDDING/ PERMITTING

TAKE 5 OIL CHANGE
1471 MOUNT HOPE, ROCHESTER, NY

SITE PLAN



SHEET

C-100

CHECKED BY
XXX

DRAWN BY
XXX

JOB # 223023

DATE **06-14-23**

	REVISED
--	----------------

© 2023 MUSSACHIO ARCHITECTS P.C.

SITE PLAN

SCALE: 1/8" = 20'-0"

